

REVISIONS	
1	4/10/98 ENT. ROUND, DRAIN.



DRAWN BY: JR
 DESIGNED BY: PAF
 CHECKED BY: RCM


MERRILL ASSOCIATES, INC.
 REGISTERED PROFESSIONAL ENGINEERS AND LAND SURVEYORS
 427 COLUMBIA ROAD - HANOVER, MA 02339
 TEL (781) 826-9200 FAX (781) 826-6665

SITE PLAN — WHITING STREET — HINGHAM, MASSACHUSETTS
 APPLICANT: FORE SEASONS GOLF & PRACTICE AND LEARNING CENTER
 C/O BAKER, BRAVERMAN & BARBADORO, P.C.
 50 BRANTREE HILL PARK
 BRANTREE, MA 02154

MARCH 10, 1998
 SCALE: 1" = 40'
 JOB NO. 96-165
 LATEST REVISION: APRIL 10, 1998

- TOPOGRAPHY
- UTILITIES
- EROSION CONTROL

H:\96-165\TOP.DWG, 3/17/2004, 1:29:29 PM

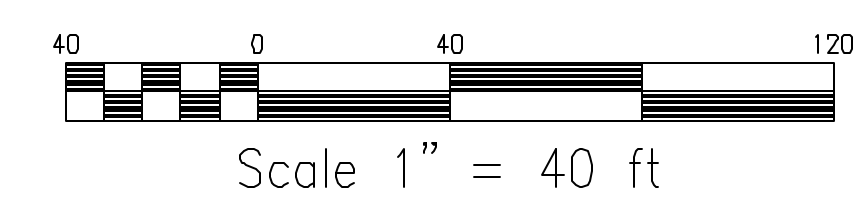

NOTE:
 NO WELLS WERE LOCATED, OBSERVED OR KNOWN TO EXIST WITHIN 500' OF THE PROPOSED SEPTIC SYSTEM.